




design resource group

- landscape architecture
- civil engineering
- urban design
- land planning
- traffic engineering
- transportation planning

2459 wilkinson boulevard, suite 200
charlotte, nc 28208
p 704.343.0608 f 704.358.3093
www.drgp.com

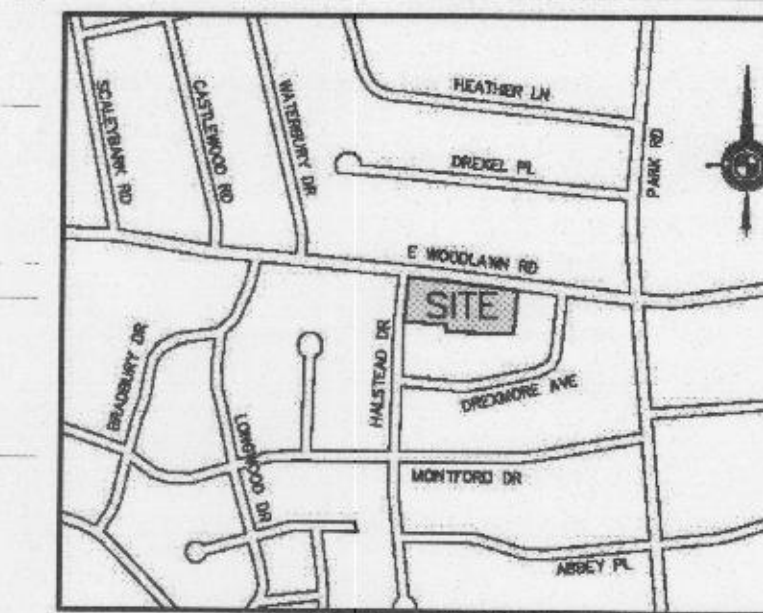

VICINITY MAP
NOT TO SCALE

DREXMORE AVENUE
50' PUBLIC R/W
M.B. 6, PG. 411
APR 04 2016

APPROVED BY
CITY COUNCIL
FEB 15 2016

THE TOWNS AT MADISON PARK
CHARLOTTE, NC

RICHTER DEVELOPMENT, LLC
2410 DUNAVANT STREET
CHARLOTTE, NC 28203
704.651.1768

REZONING PETITION
#2016 - 013

SCALE: 1"=30'


PROJECT #: 554-002
DRAWN BY: BG
CHECKED BY: BS

TECHNICAL
DATA PLAN

OCTOBER 22, 2015

REVISIONS:
12/18/15 PER STAFF COMMENTS
01/21/16 FOR ZONING COMMITTEE
02/02/16 PER STAFF COMMENTS

RZ1.00

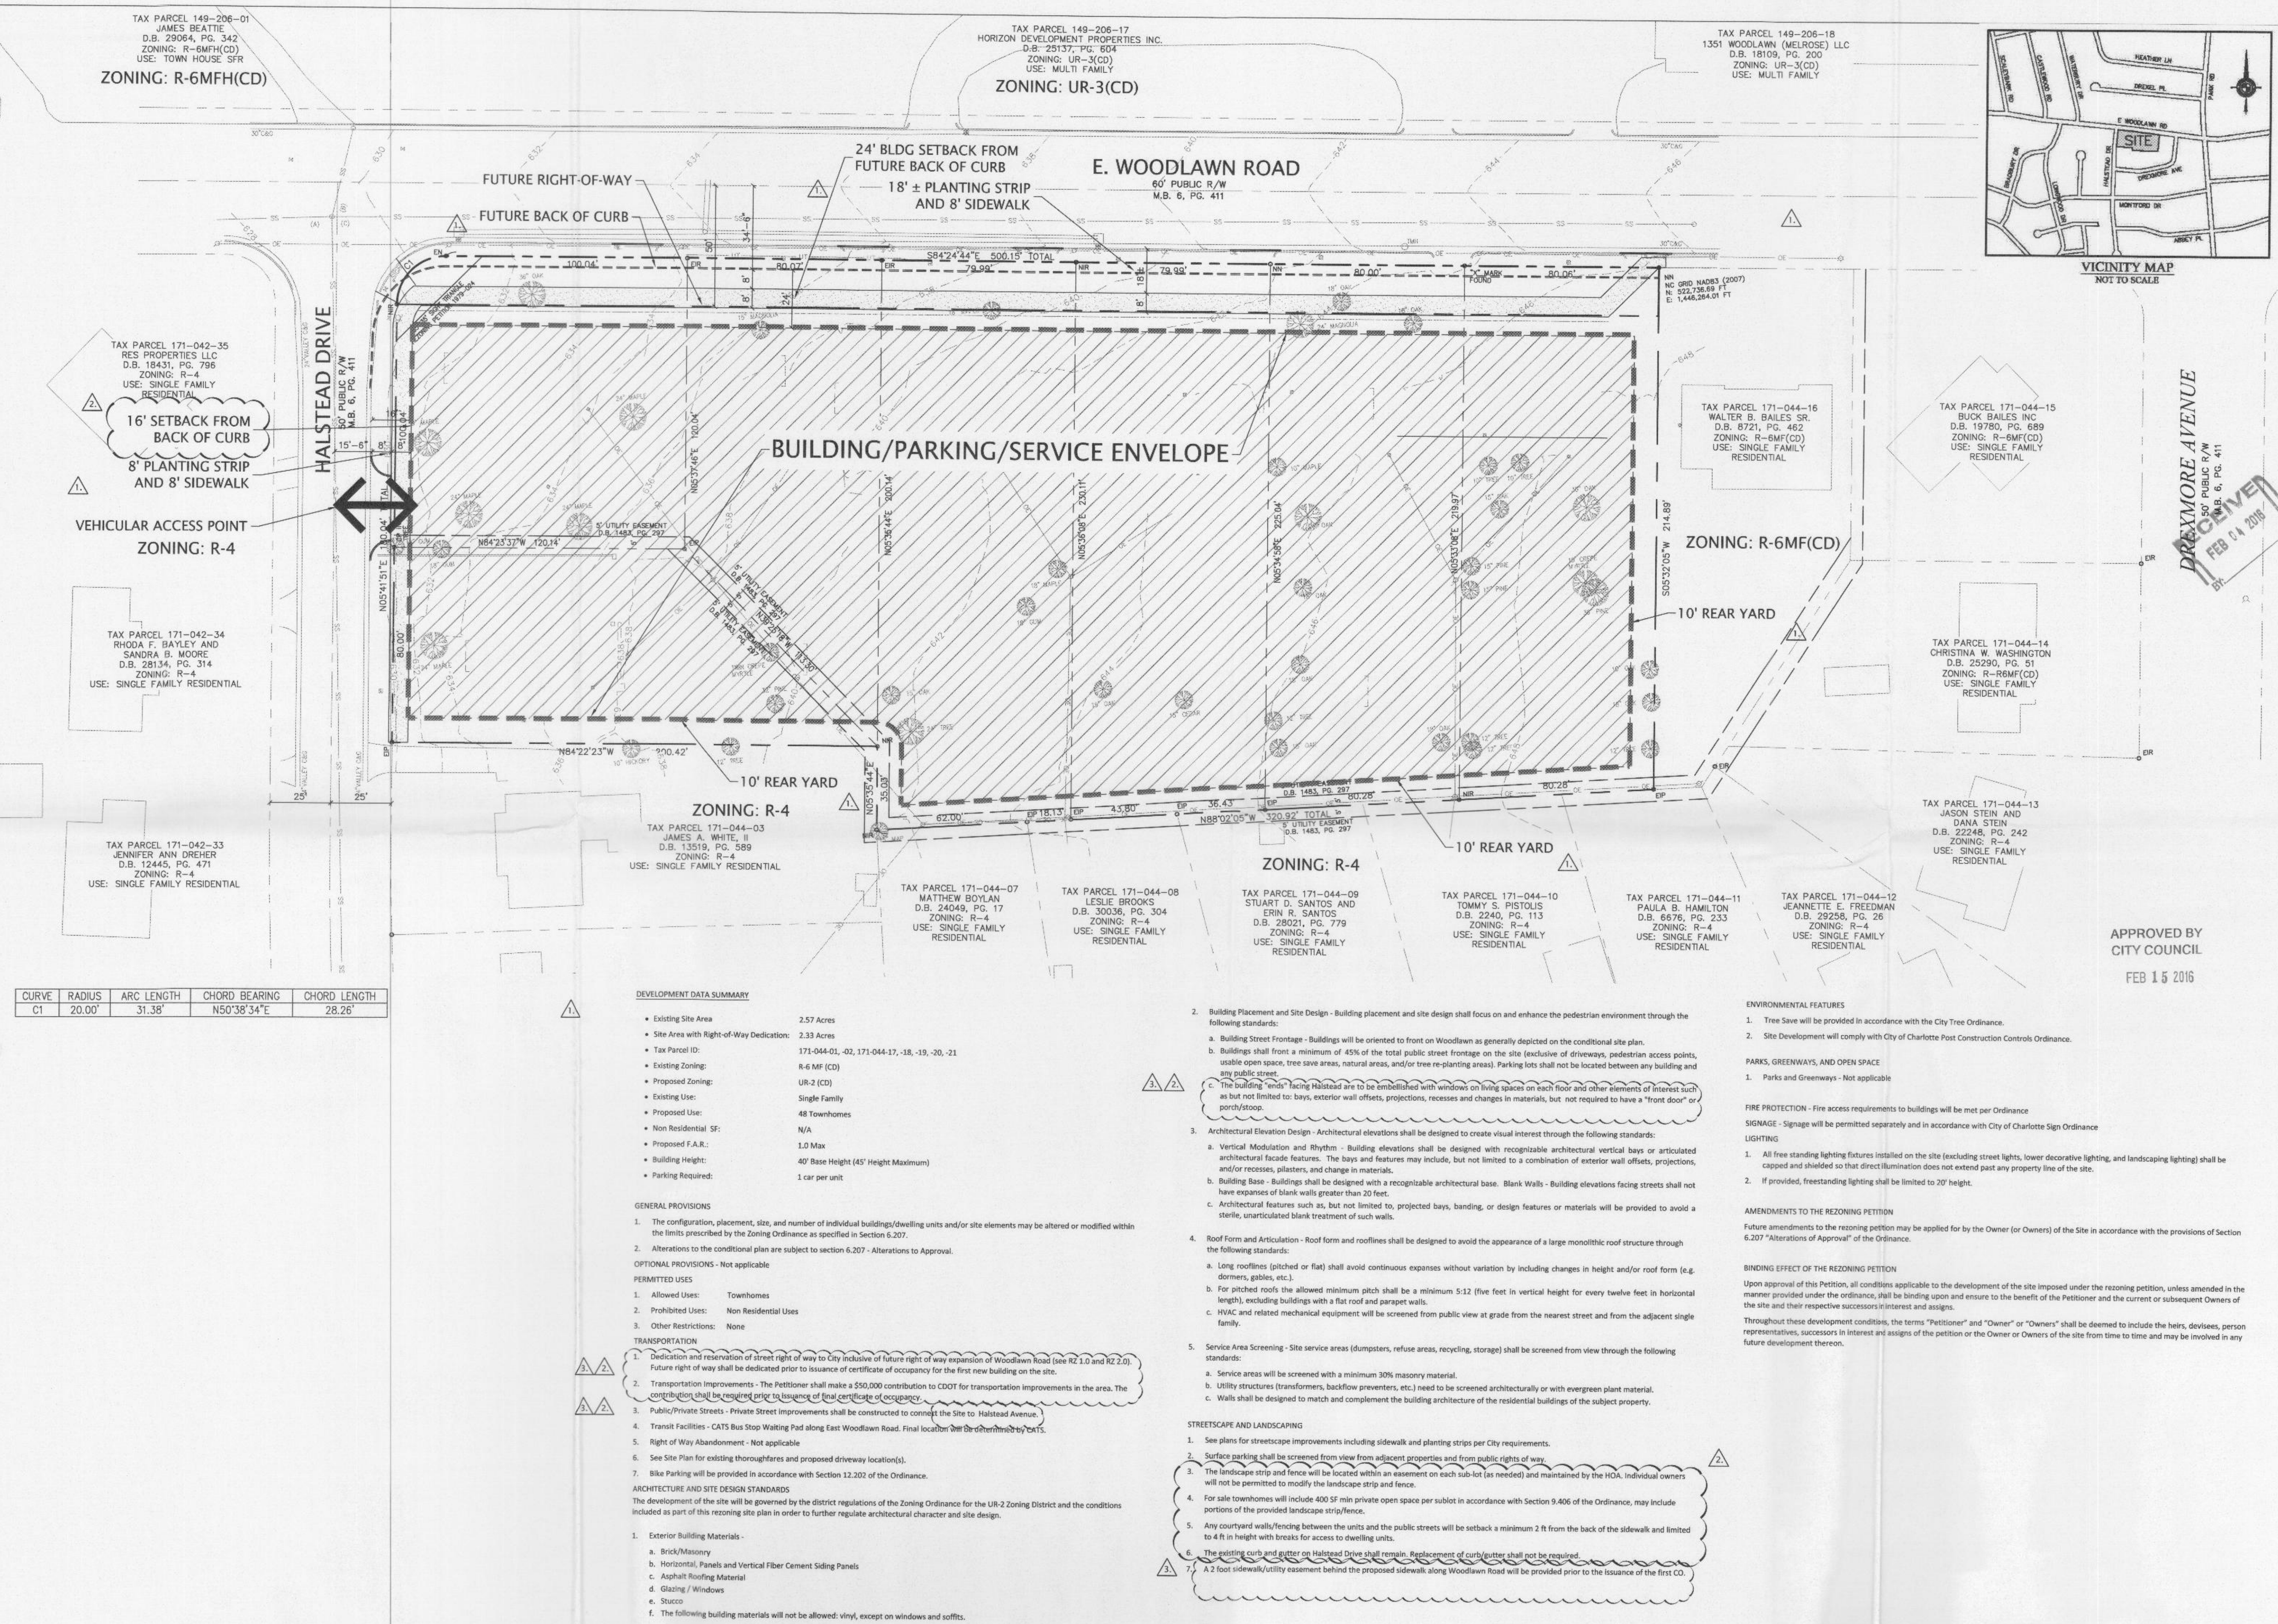



design resource group


- landscape architecture
- civil engineering
- urban design
- land planning
- traffic engineering
- transportation planning

2459 wilkinson boulevard, suite 200
 charlotte, nc 28208
 p 704.343.0608 f 704.358.3093
 www.drgrp.com

THE TOWNS AT MADISON PARK
 CHARLOTTE, NC

RICHTER DEVELOPMENT, LLC
 2410 DUNAVANT STREET
 CHARLOTTE, NC 28203
 704.651.1768

REZONING PETITION
 #2016 - 013

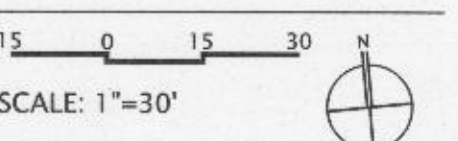


PROJECT #: 554-002
 DRAWN BY: BC
 CHECKED BY: BS

**SCHEMATIC
 SITE PLAN**

OCTOBER 22, 2015

- REVISIONS:
- 12/18/15 PER STAFF COMMENTS
 - 01/21/16 FOR ZONING COMMITTEE
 - 02/02/16 PER STAFF COMMENTS

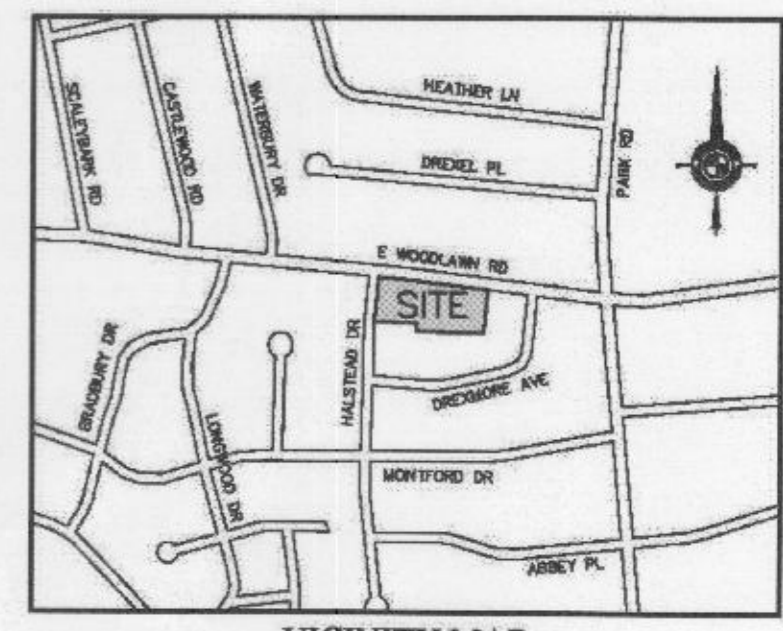

VICINITY MAP
 NOT TO SCALE

APPROVED BY
 CITY COUNCIL
 FEB 15 2016

