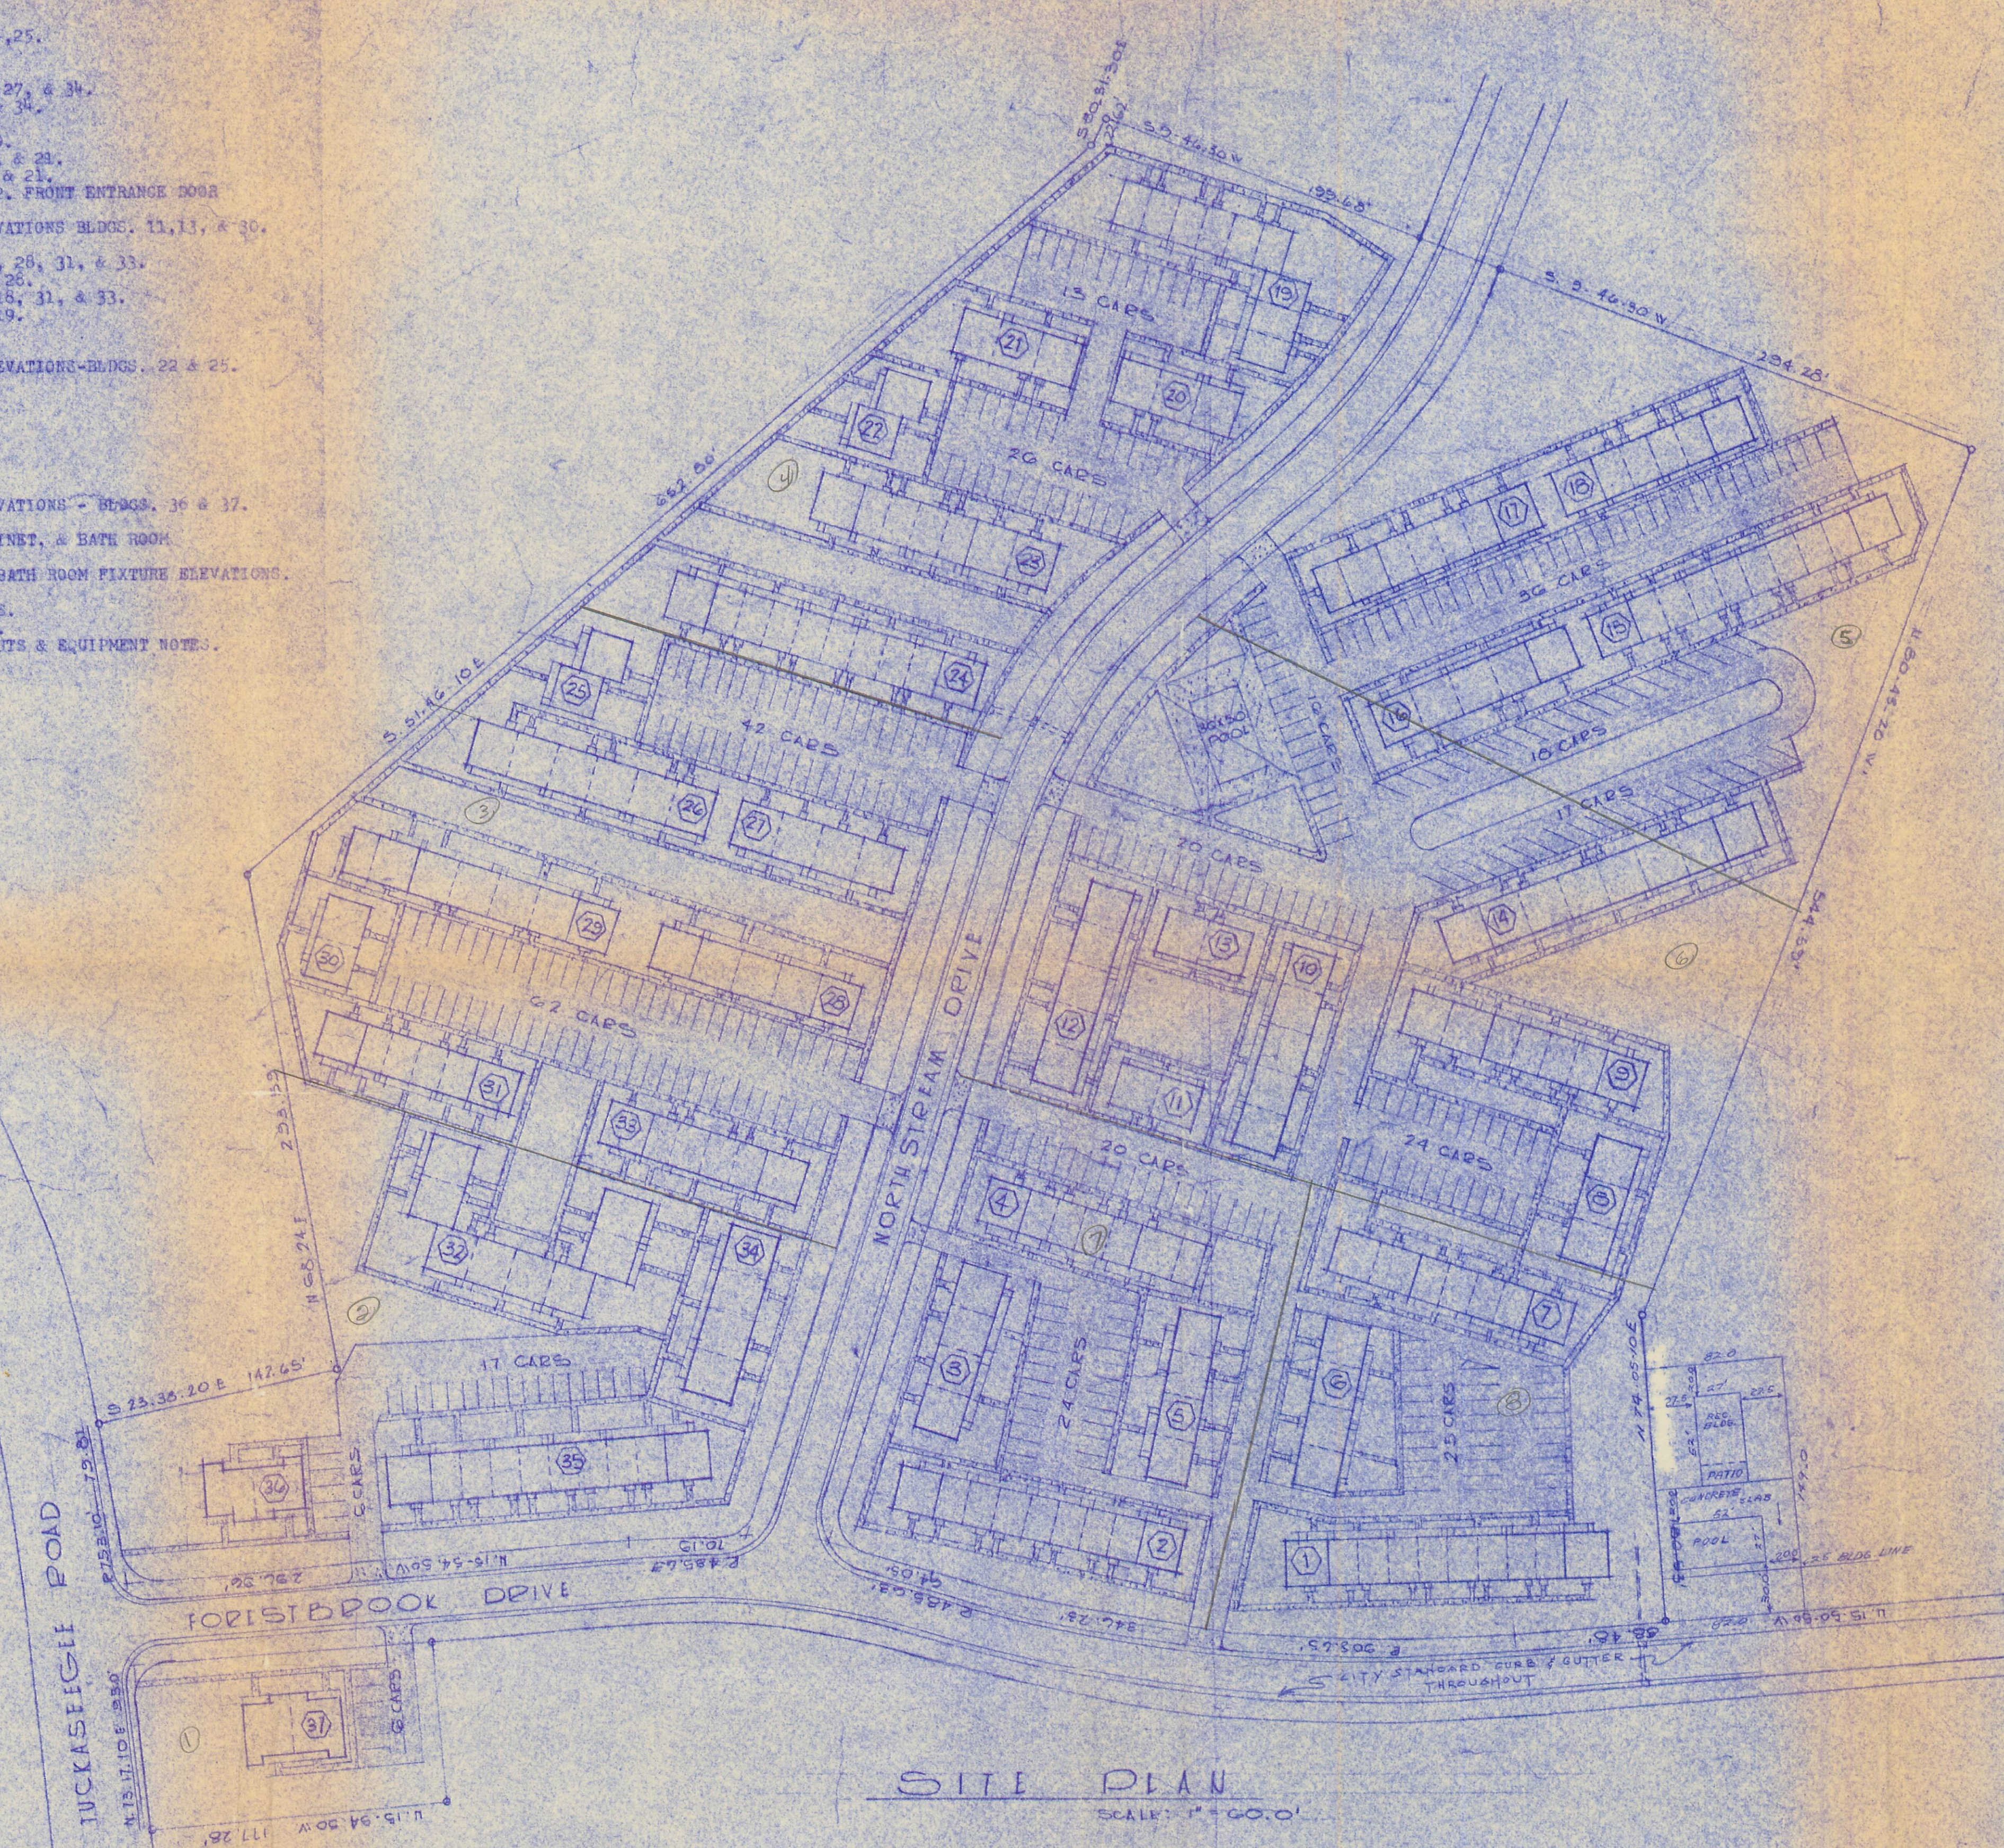



SCHEDULE OF DRAWINGS

SHEET	CONTENTS
1	SITE PLAN AND PROJECT SUMMARY
2	FOUNDATION PLAN & FLOOR PLANS - BLDGS. 1, 13, 24, 25
3	EXTERIOR ELEVATIONS - BLDGS. 1, 2, 13, 24, 25
4	FOUNDATION PLAN & FLOOR PLANS - BLDG. 2
5	EXTERIOR ELEVATIONS - BLDGS. 2, 5, 6, 27, & 34
6	FOUNDATION PLAN & FLOOR PLANS - BLDGS. 3, 4, 6, 7, 9, 27, & 34
7	EXTERIOR ELEVATIONS - BLDGS. 3, 4, 6, 7, 9, 27, & 34
8	FOUNDATION PLAN & FLOOR PLANS - BLDGS. 7 & 9
9	EXTERIOR ELEVATIONS - BLDGS. 9, 20, & 24
10	FOUNDATION PLAN & FLOOR PLANS - BLDGS. 10 & 12
11	EXTERIOR ELEVATIONS - BLDGS. 10 & 12
12	FOUNDATION PLAN, FLOOR PLAN, & EXTERIOR ELEVATIONS - BLDGS. 13, 13, & 30
13	EXTERIOR ELEVATIONS - BLDG. 14
14	FOUNDATION PLAN & FLOOR PLANS - BLDGS. 14, 15, 17, 18, 28, 31, & 33
15	EXTERIOR ELEVATIONS - BLDGS. 15 & 26
16	FOUNDATION PLAN & FLOOR PLANS - BLDGS. 17, 18, 31, & 33
17	EXTERIOR ELEVATIONS - BLDG. 19
18	FOUNDATION PLAN & FLOOR PLANS - BLDG. 19
19	EXTERIOR ELEVATIONS - BLDG. 19
20	FOUNDATION PLAN, FLOOR PLAN, & EXTERIOR ELEVATIONS - BLDGS. 22 & 25
21	EXTERIOR ELEVATIONS - BLDGS. 23, 24, 26, & 29
22	FOUNDATION PLAN & FLOOR PLANS - BLDG. 23
23	EXTERIOR ELEVATIONS - BLDG. 23
24	FOUNDATION PLAN & FLOOR PLANS - BLDG. 24
25	EXTERIOR ELEVATIONS - BLDG. 24
26	FOUNDATION PLAN & FLOOR PLANS - BLDG. 25
27	EXTERIOR ELEVATIONS - BLDG. 25
28	FOUNDATION PLAN, FLOOR PLAN, & EXTERIOR ELEVATIONS - BLDGS. 30 & 37
29	TYPICAL LARGE SCALE APARTMENT FLOOR PLANS
30	DOOR SCHEDULE, WINDOW SCHEDULE, KITCHEN CABINET, & BATH ROOM FIXTURE ELEVATIONS
31	FIXTURE ELEVATIONS
32	INTERIOR STAIR DETAILS, KITCHEN CABINET, & BATH ROOM FIXTURE ELEVATIONS
33	FIXTURE ELEVATIONS
34	SCHEMATIC LARGE SCALE ELECTRICAL FLOOR PLANS
35	SCHEMATIC LARGE SCALE ELECTRICAL FLOOR PLAN
36	HEATING & AIR CONDITIONING FLOOR PLAN LAYOUTS & EQUIPMENT NOTES



PROJECT SUMMARY					
BLOCK	1 BR APTS	2 BR APTS	3 BR APTS	NOTES	REGULATORY ELEVATIONS
1	2	7			
2	4	7			
3	2	4		LAUNDRY (5'x2')	
4	4	4			
5	4	4			
6	3	4			
7	2	4			
8	2	2			
9	2	2			
10	2	2			
100	2	2			
TOTAL	63	80	57		

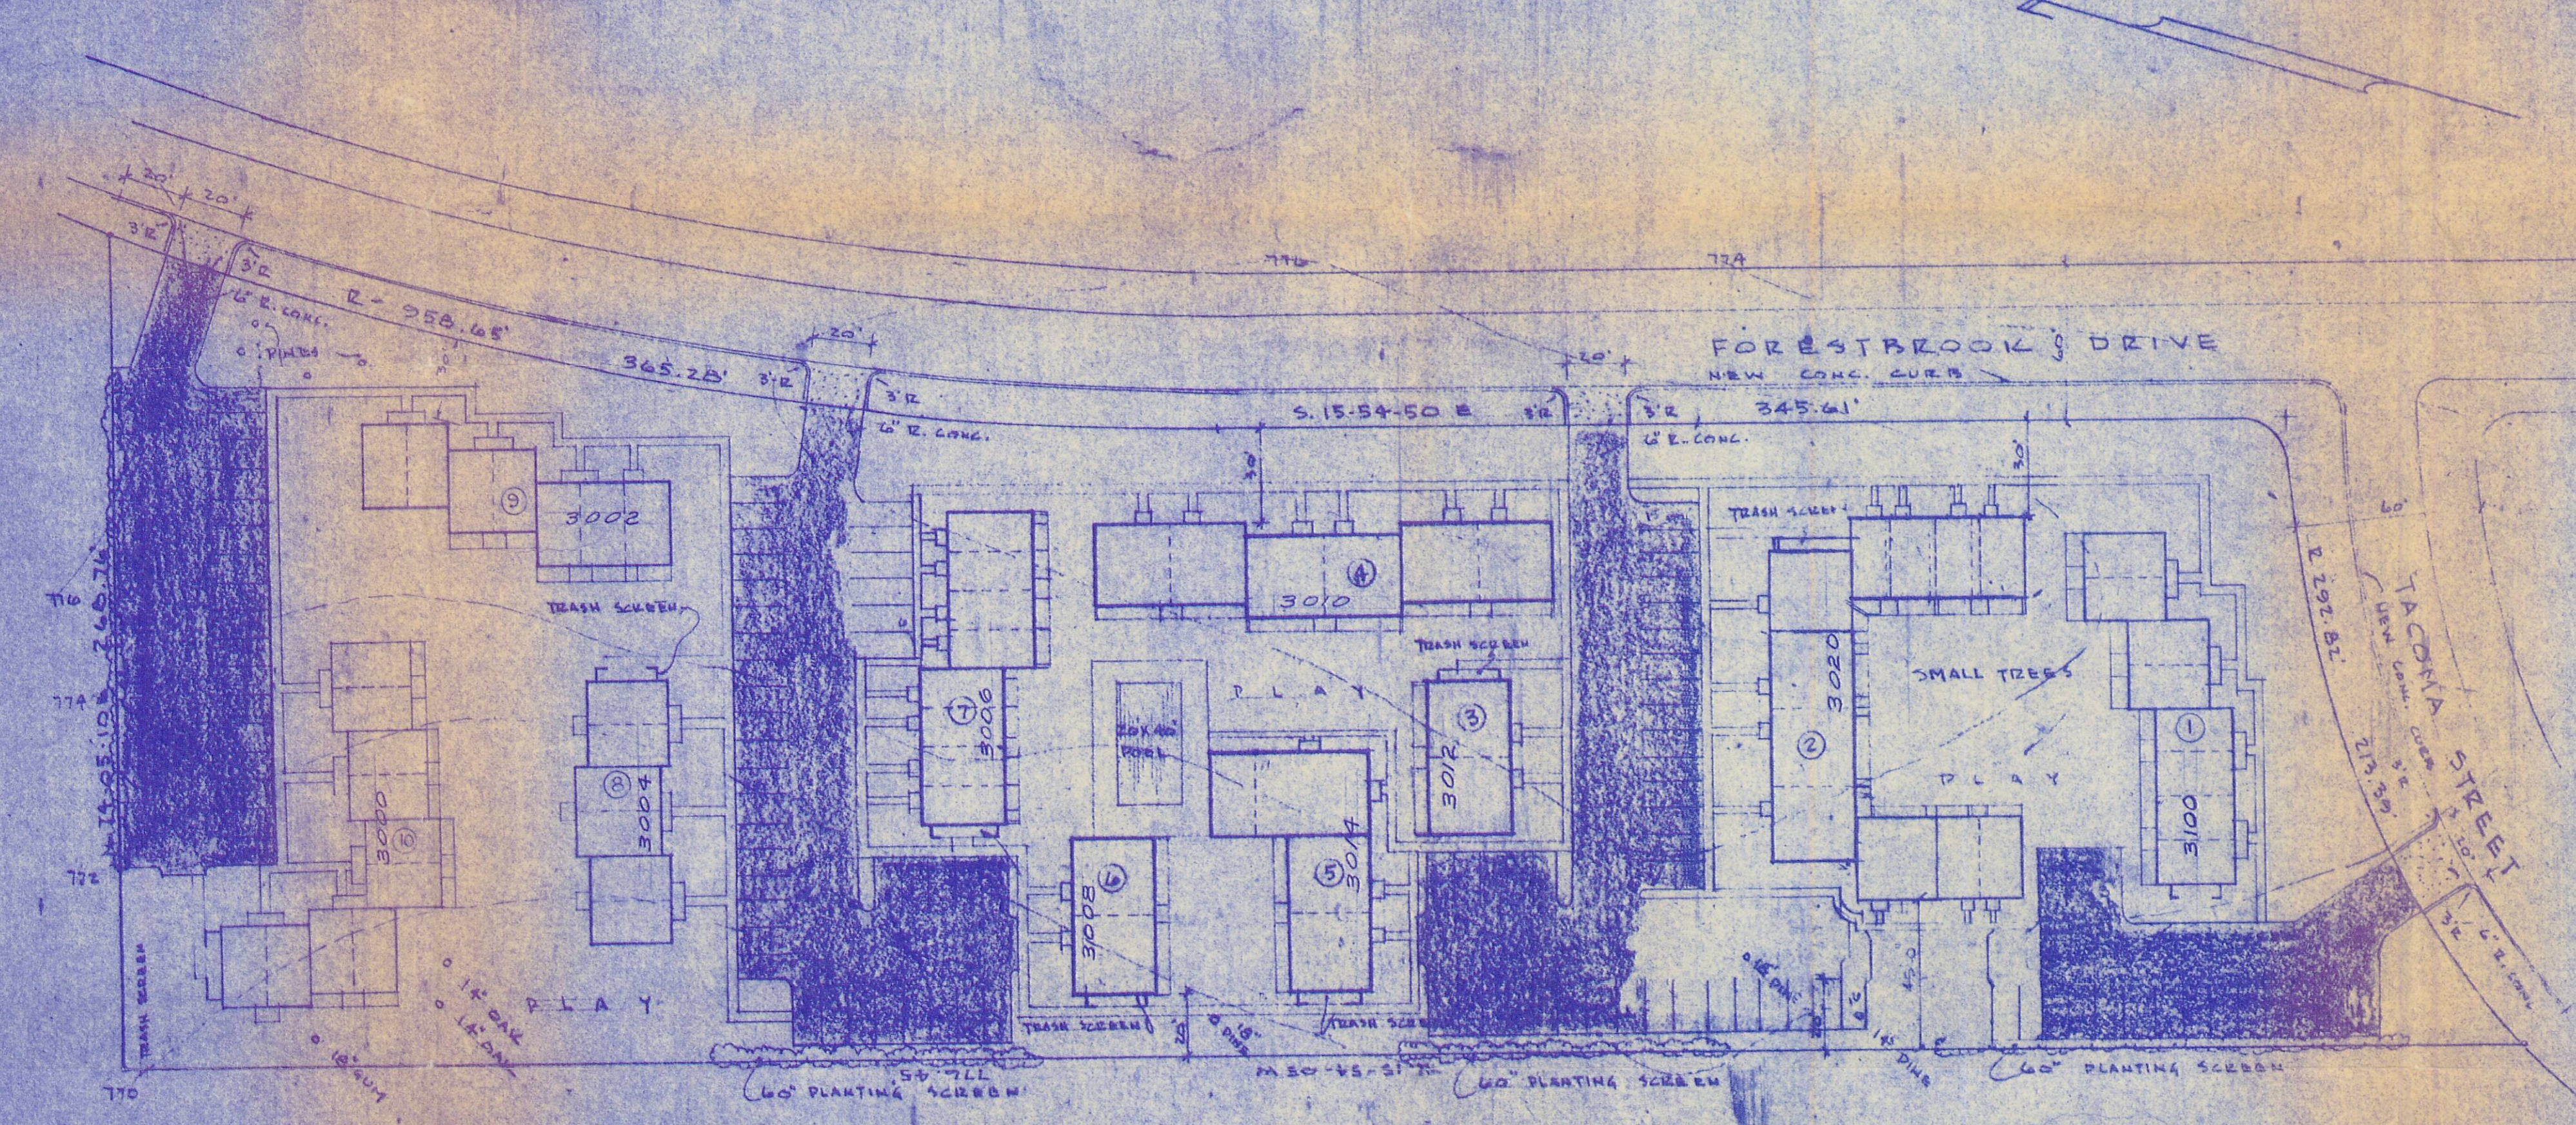DRAWN: []
 CHECKED: []
 SCALE: 1"=400'
 DATE: 9-24-70
 REVISED: 12-16-70
JACK O. BOYTE, ARCHITECT
 SYDNEY, CHARLOTTE, NORTH CAROLINA
 A 200 UNIT HOUSING DEVELOPMENT
 GREEN PINE COMPANY
 1000 WEST 10TH STREET
 CHARLOTTE, N.C. 28202



SUMMARY			
BLOCK	1 BR APTS	2 BR APTS	3 BR APTS
1	2	7	
2	4	7	
3	2	4	
4	4	4	
5	4	4	
6	3	4	
7	2	4	
8	2	2	
9	2	2	
10	2	2	
100	2	2	
TOTAL	63	80	57

JACK O. BOYTE, ARCHITECT
 SYDNEY, CHARLOTTE, NORTH CAROLINA
 A 200 UNIT HOUSING DEVELOPMENT
 GREEN PINE COMPANY
 1000 WEST 10TH STREET
 CHARLOTTE, N.C. 28202

73-03